


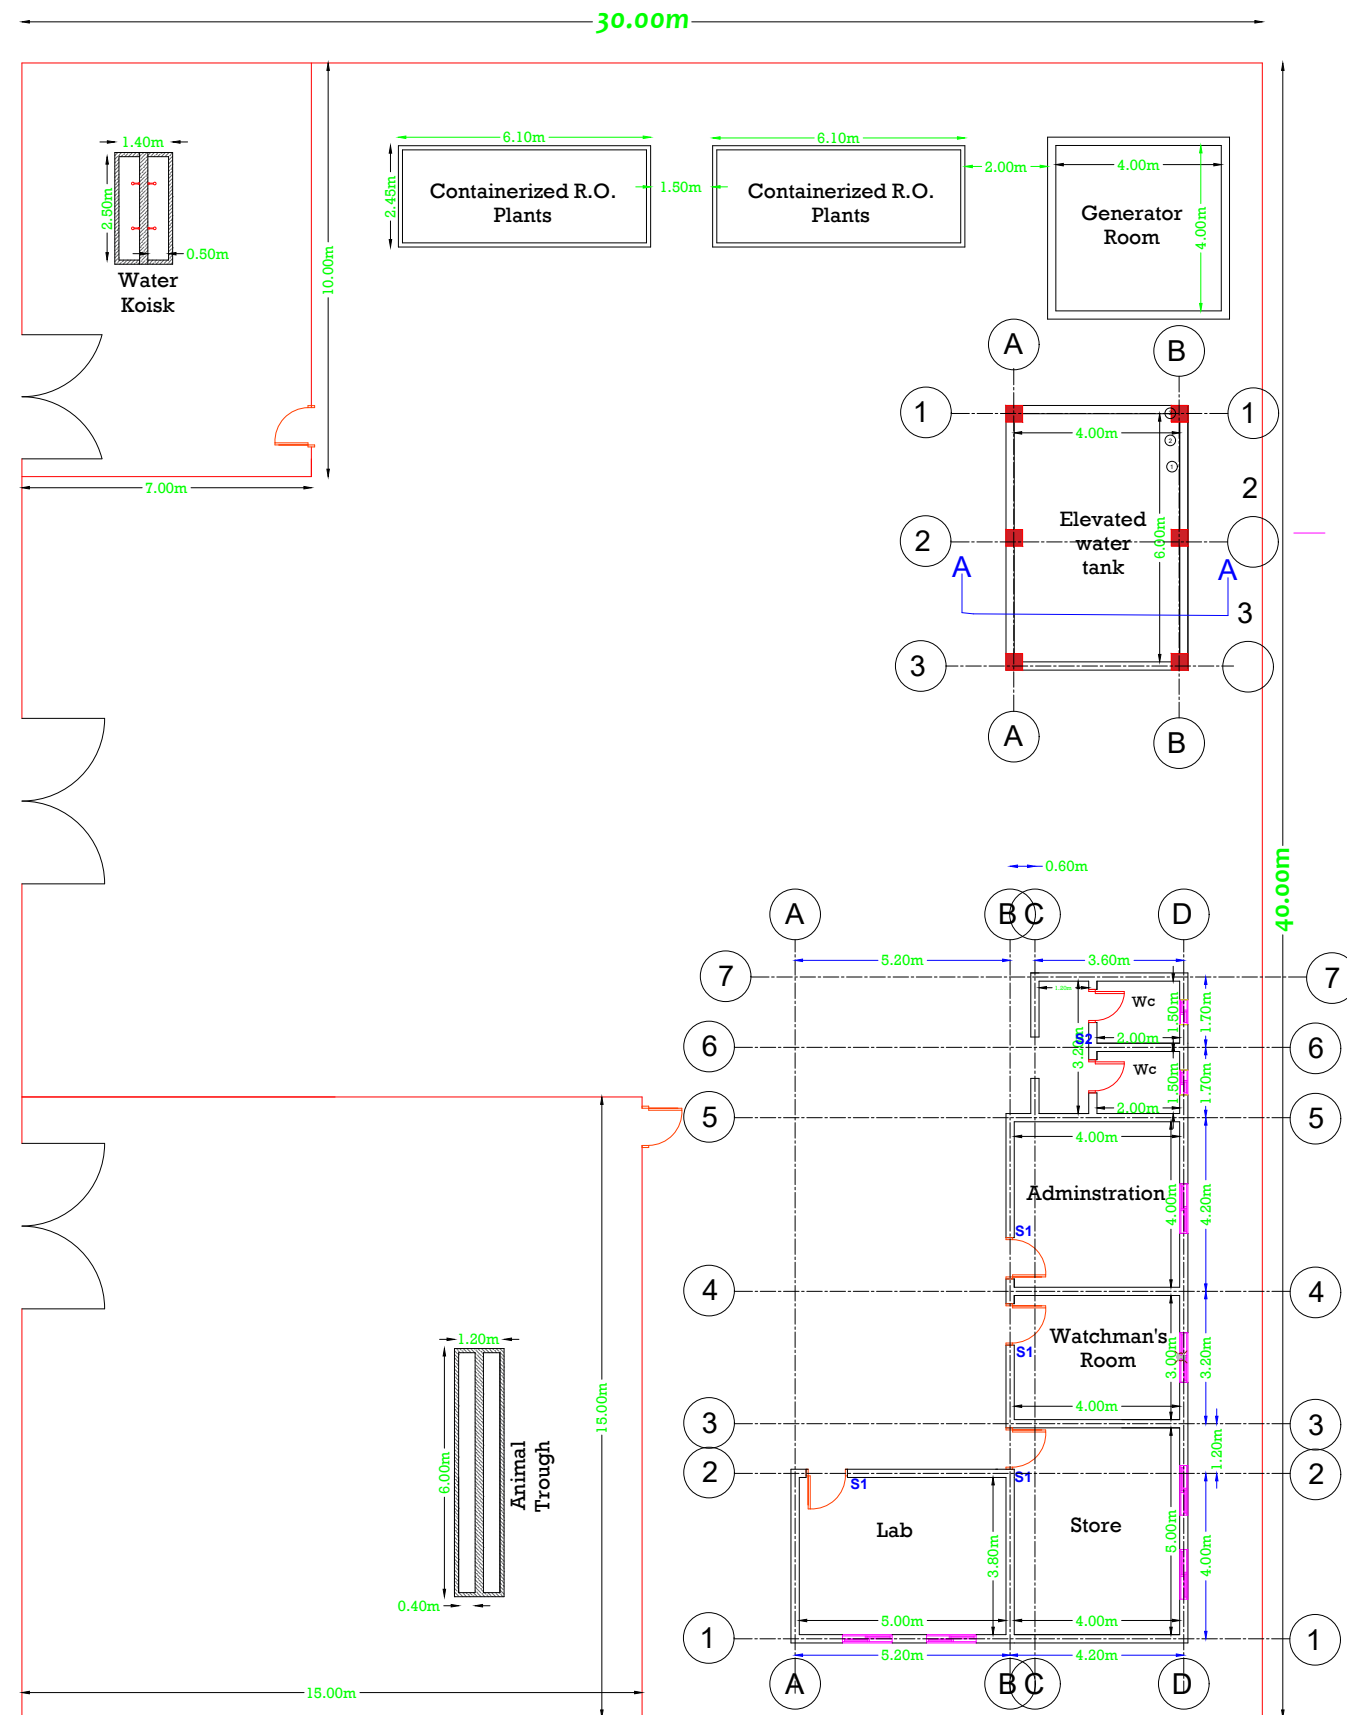

قطر الخيرية
QATAR CHARITY

Desalination Plant

June, 2023



..\Desktop\QC Logo.jpg

**Somalia
Office**

E-mail: mabdi@qcharity.org

Project Name: Reverse Osmotic Project

Sheet Content: **Foundation**


Date: June, 2023


Designed:
Eng. Mohamed Abdi

Drawn:
Eng. Abdirabbi Mohamud

Approved:
Eng. Mohamed Abdi

Sheet #: **1/5**

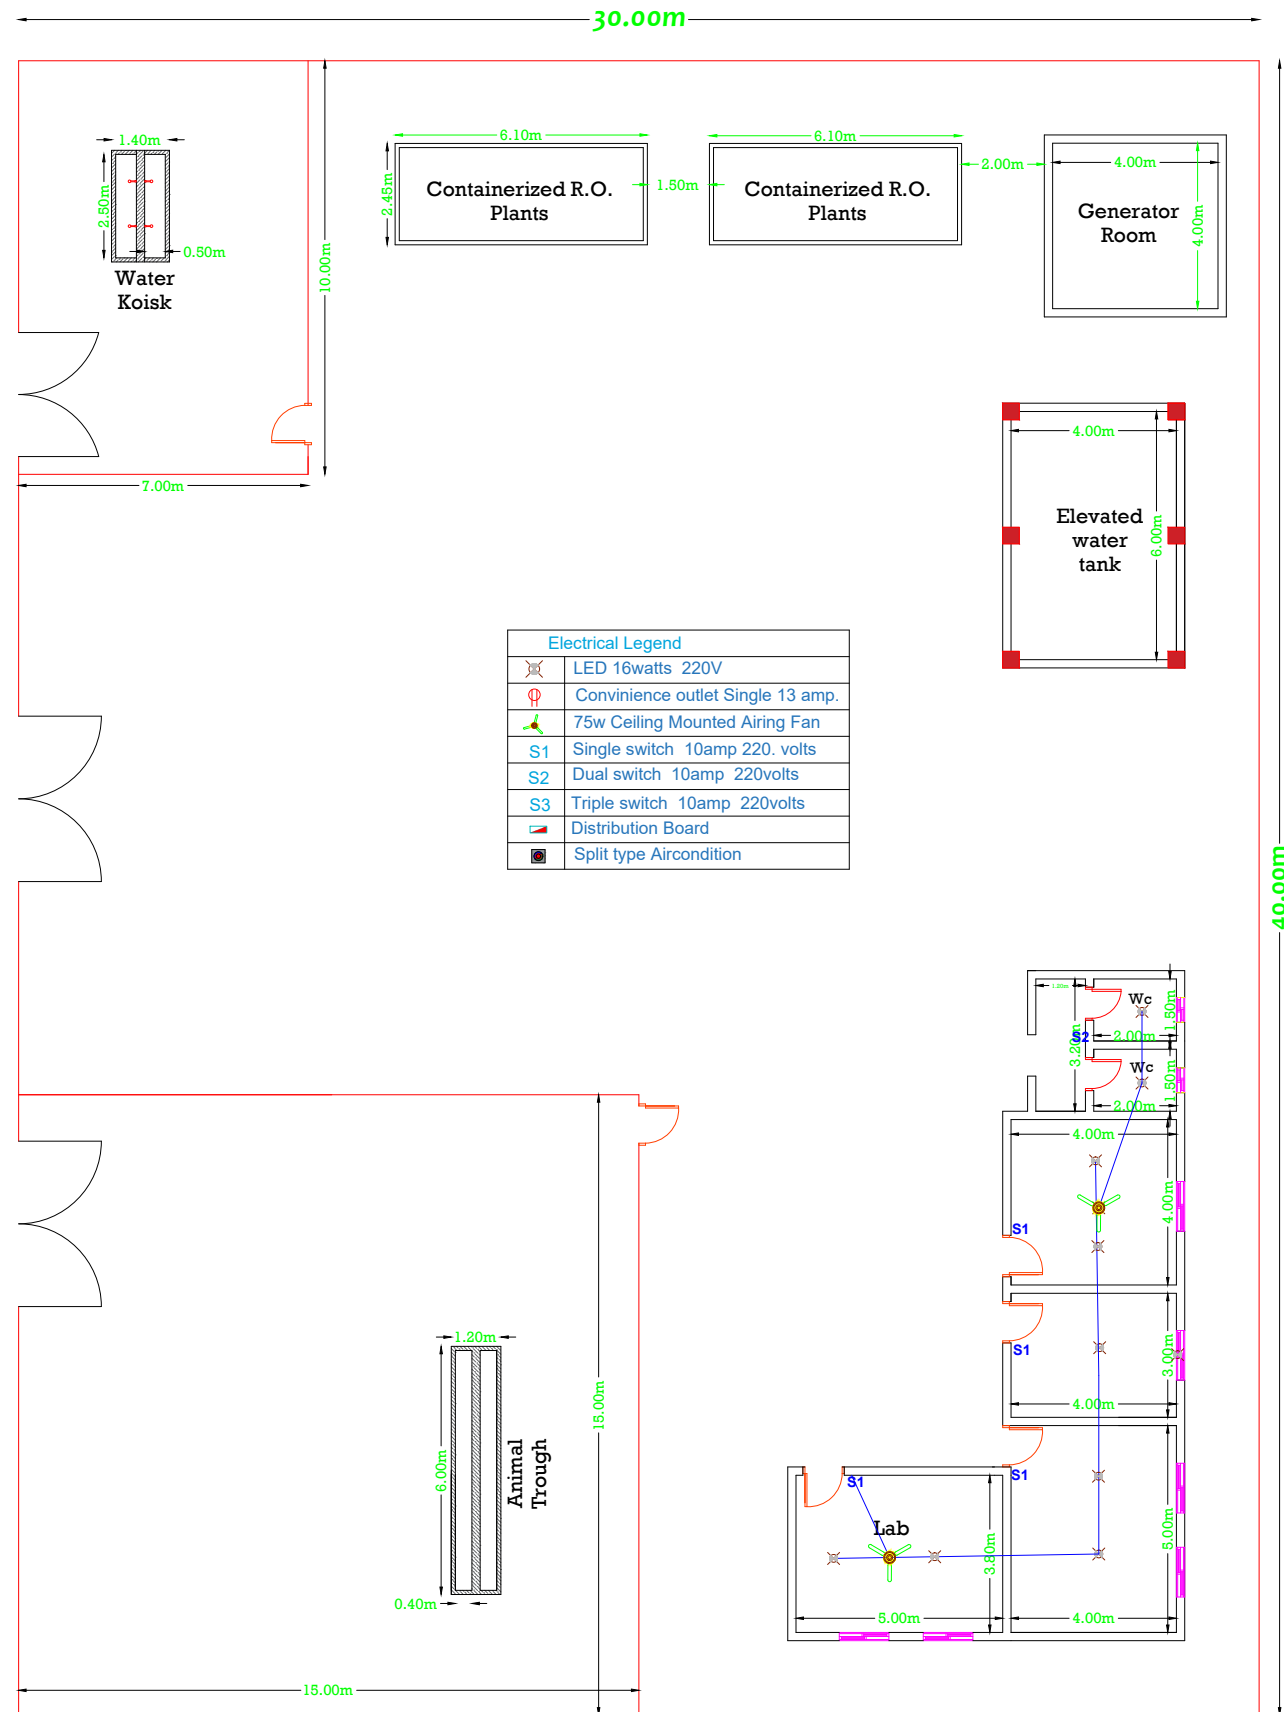



Somalia Office

E-mail: mabdi@qcharity.org

Project Name: R.O. PROJECT


Sheet Content: **Electric Plan**
Date: June, 2023


Designed:
Eng. Mohamed Abdi







Drawn:
Eng. Abdirabbi Mohamud


Approved:
Eng. Mohamed Abdi

Sheet #: **2/5**

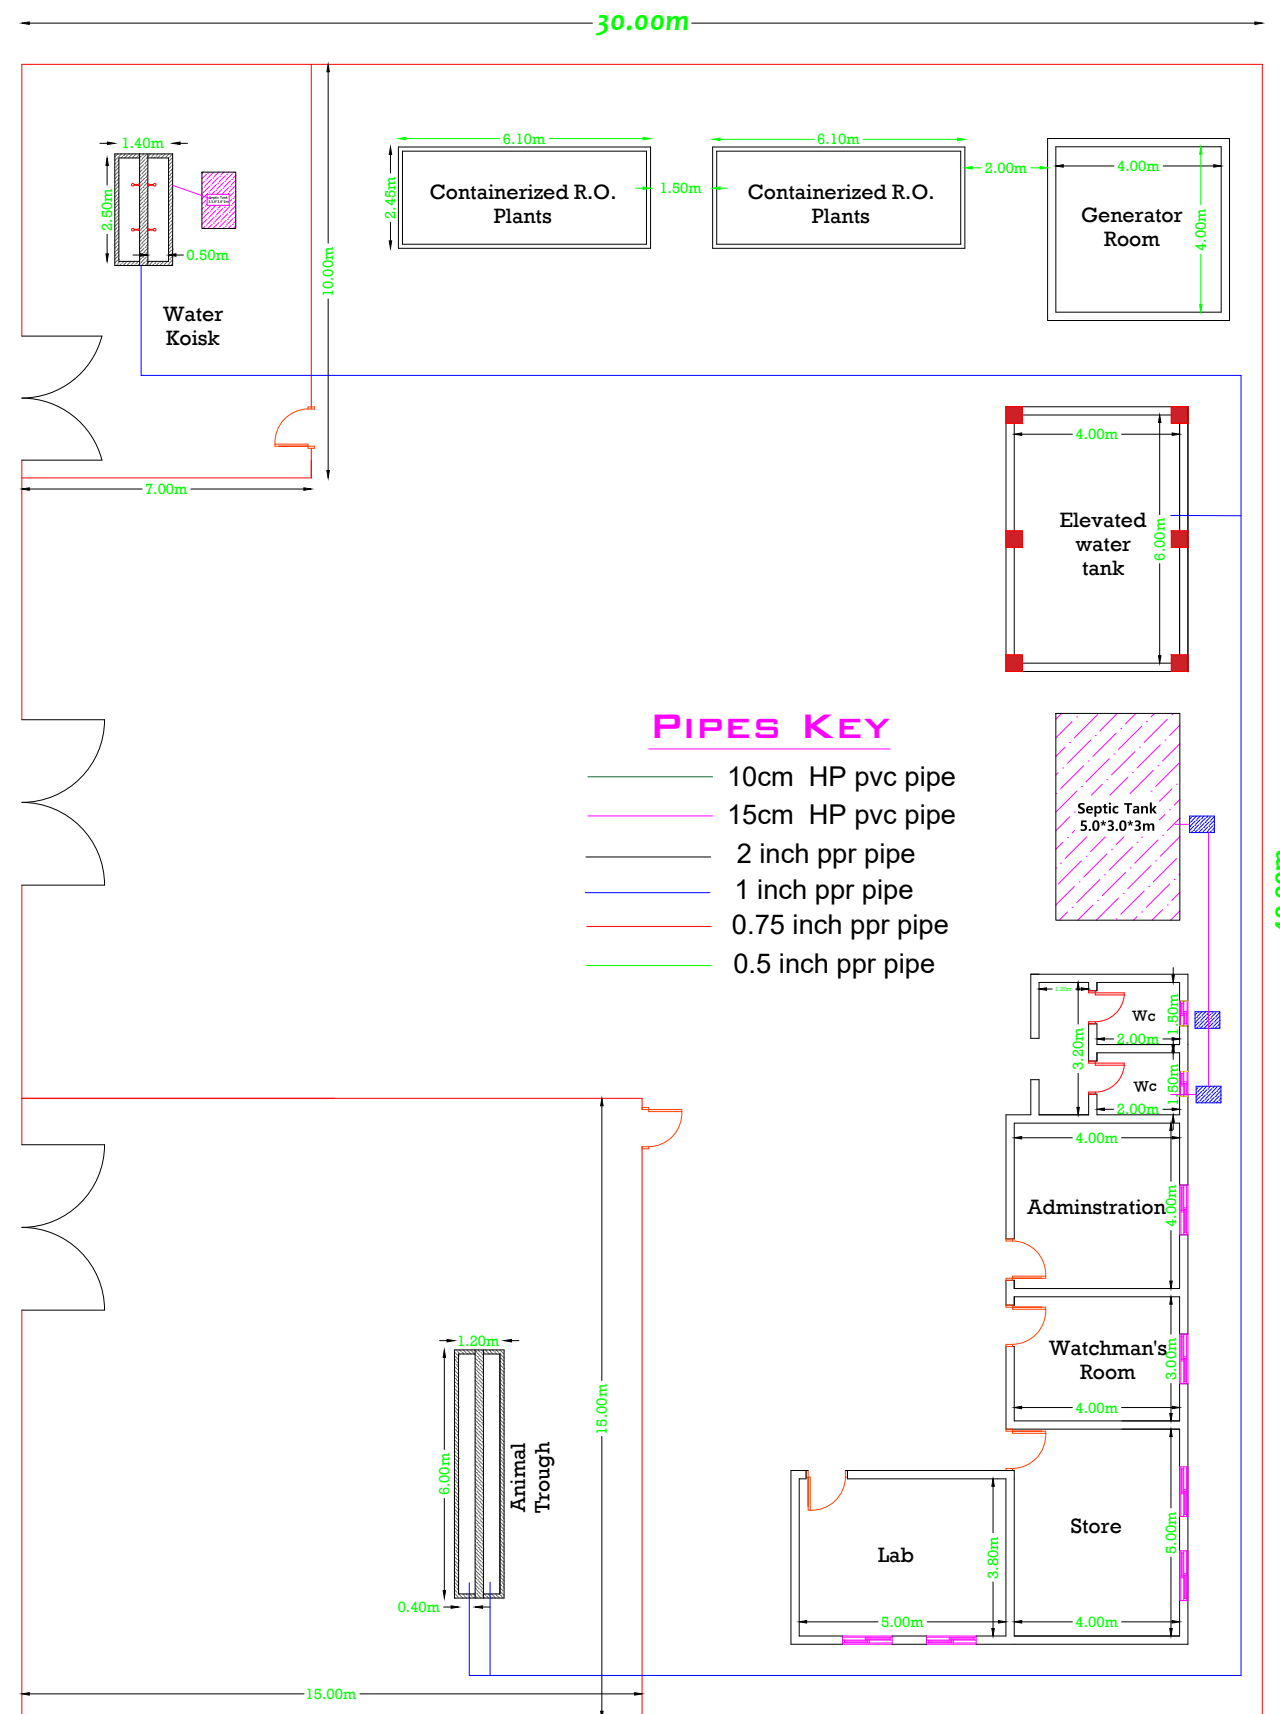

| | |
|---|--------------------------------------|
|  Somalia Office | |
| E-mail: mabdi@qcharity.org | |
| Project Name: R.O. PROJECT | |
| Sheet Content: Plumbing Plan | Date: June, 2023 |
| Designed: Eng. Mohamed Abdi | Drawn: Eng. Abdirabbi Mohamud |
| Approved: Eng. Mohamed Abdi | Sheet #: 3/5 |

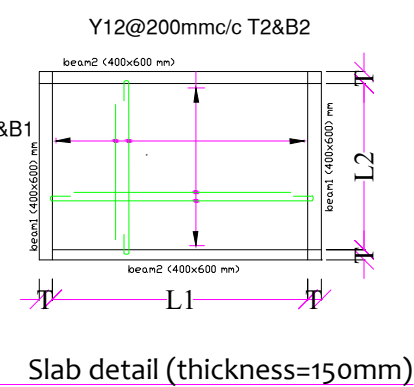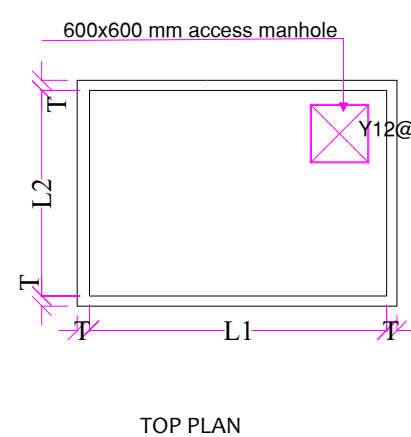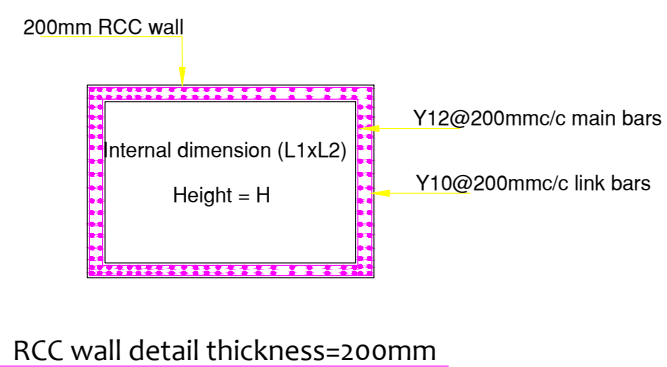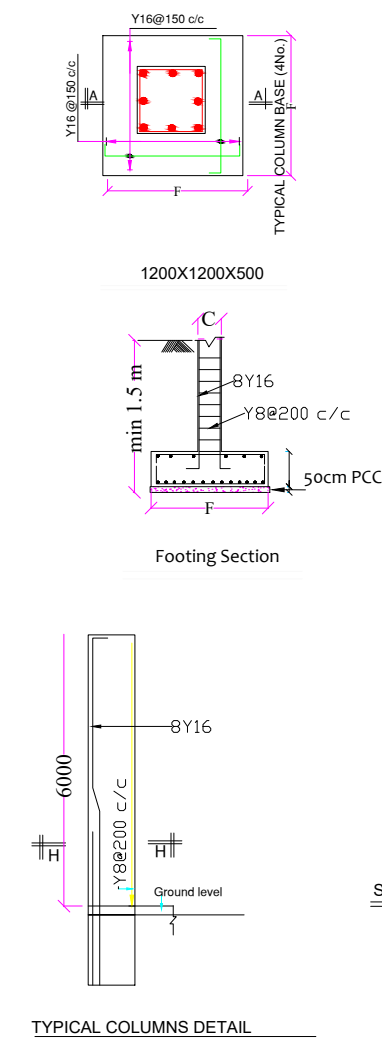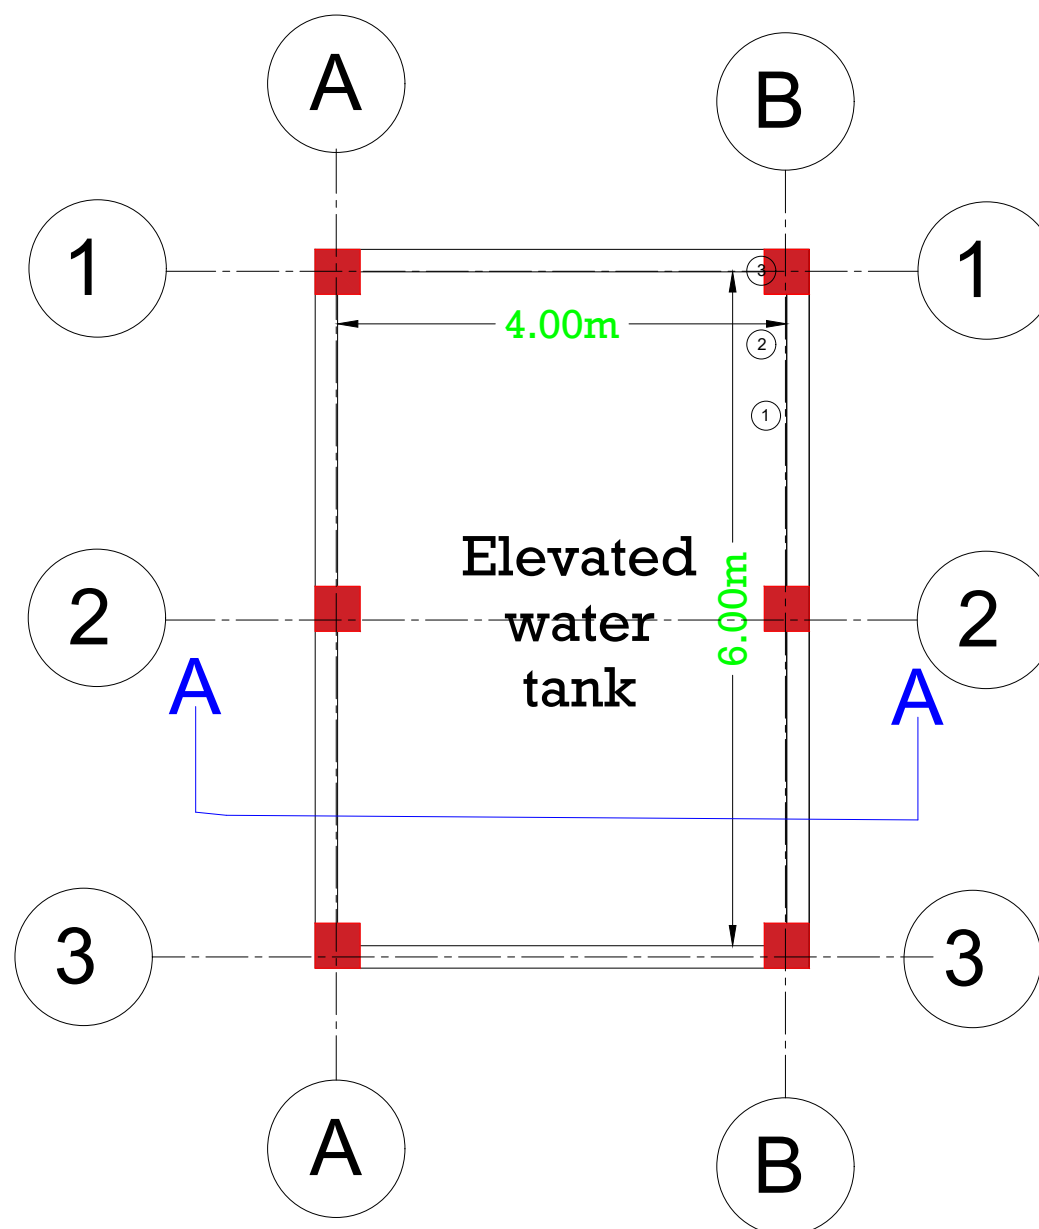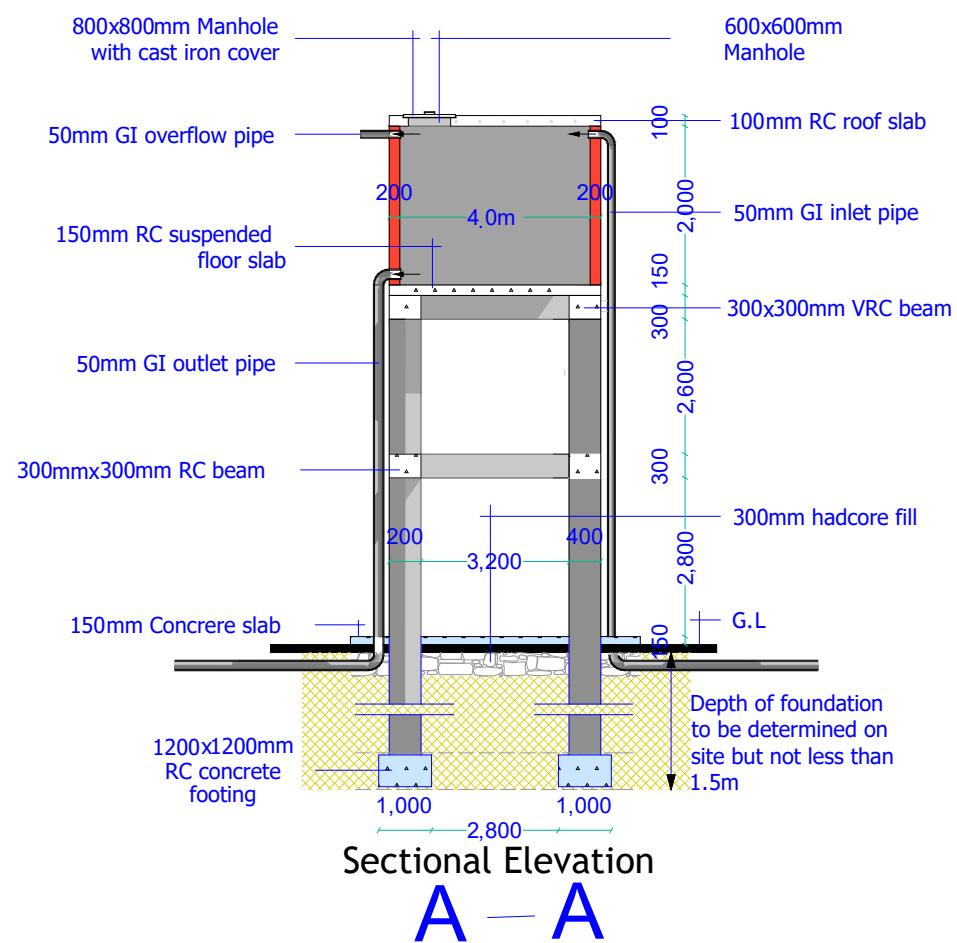



Somalia Office

E-mail: mabdi@qcharity.org

Project Name: R.O. PROJECT


Sheet Content: **Water Tank Detail**
Date: **June, 2023**

Designed: **Eng. Mohamed Abdi**


Drawn: **Eng. Abdirabbi Mohamud**

Approved: **Eng. Mohamed Abdi**


Sheet #: **4/5**

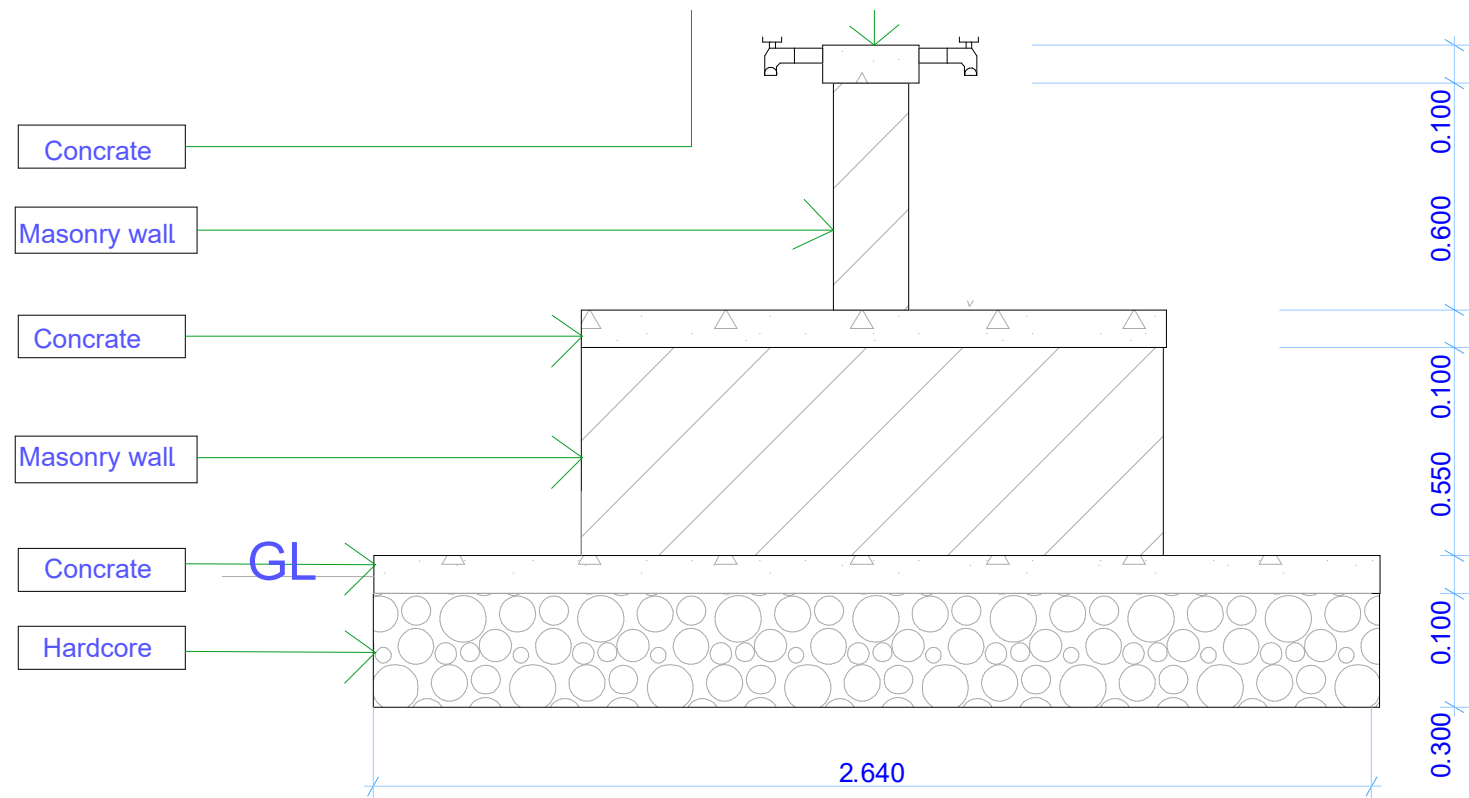


Section S-01

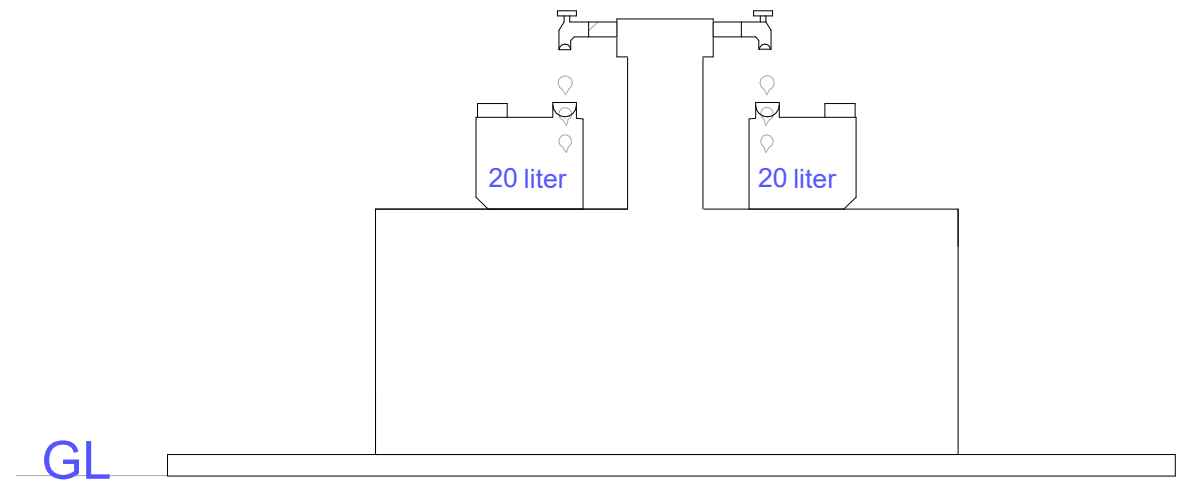

Side Elevation

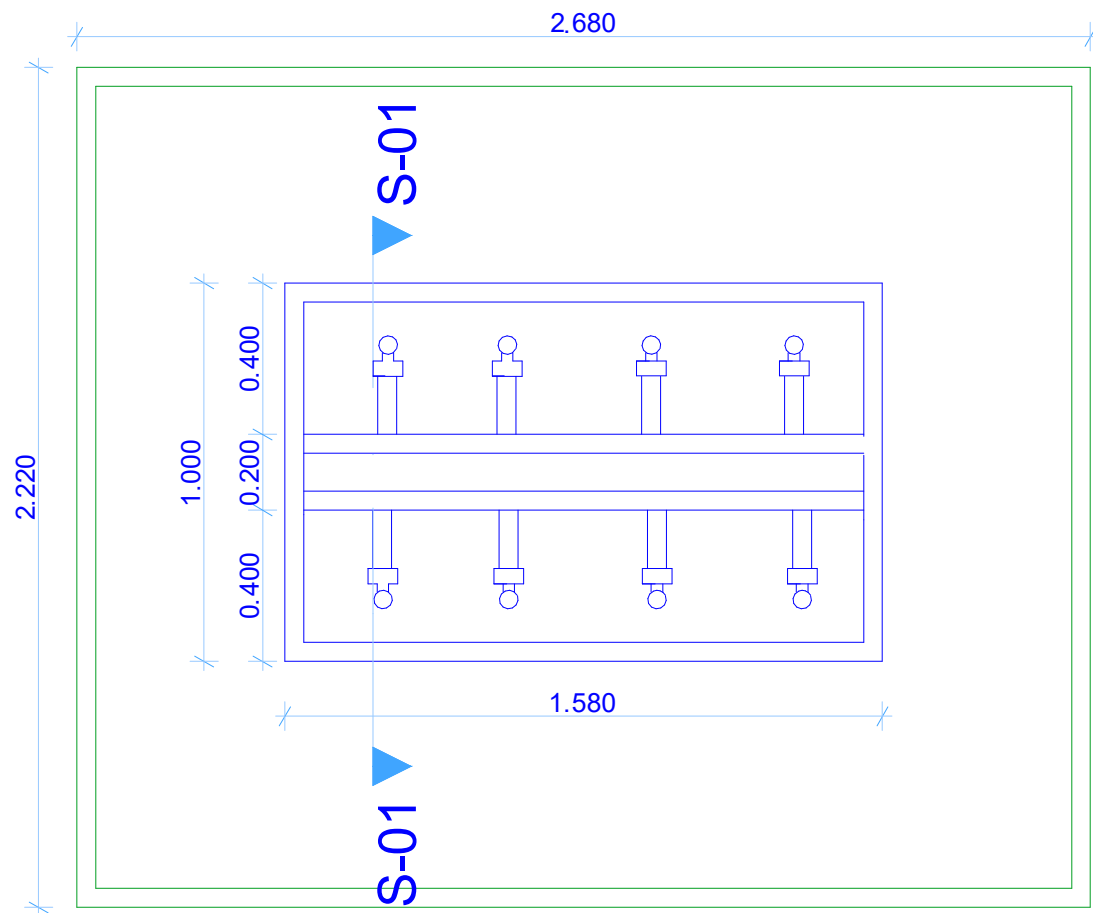

Floor Plan

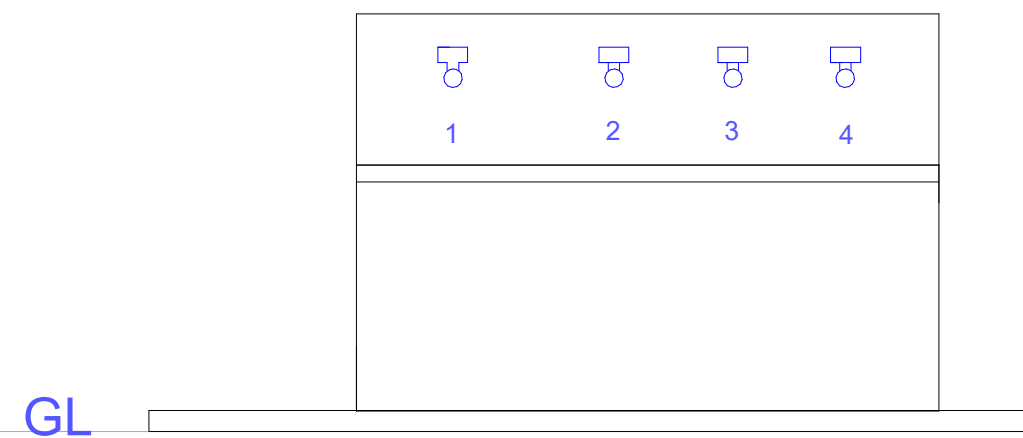

Front Elevation

| | |
|--|--------------------------------------|
| ..\Desktop\QC Logo.jpg | Somalia Office |
| E-mail: mabdi@qcharity.org | |
| Project Name: R.O. PROJECT | |
| Sheet Content: <i>Water Kiosks Details</i> | Date: <i>June, 2023</i> |
| Designed: <i>Eng. Mohamed Abdi</i> | Drawn: <i>Eng. Abdirabbi Mohamud</i> |
| Approved: <i>Eng. Mohamed Abdi</i> | Sheet #: 5/5 |