

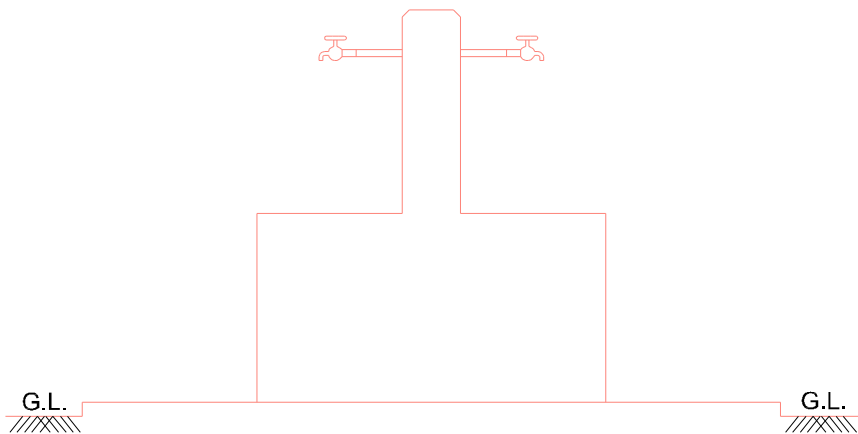


LIST OF PIPE FITTINGS

- 1. HDP PIPE
- 2. BRASS UNION
- 3. G.I. NIPPLE
- 4. VALVE BOX
- 5. GLOBE VALVE
- 6. G.I. PIPE
- 7. G.I. ELBOW
- 8. G.I. SOCKET
- 9. BRASS TAP
- 10. G.I. CROSS
- 11. G.I. TEE

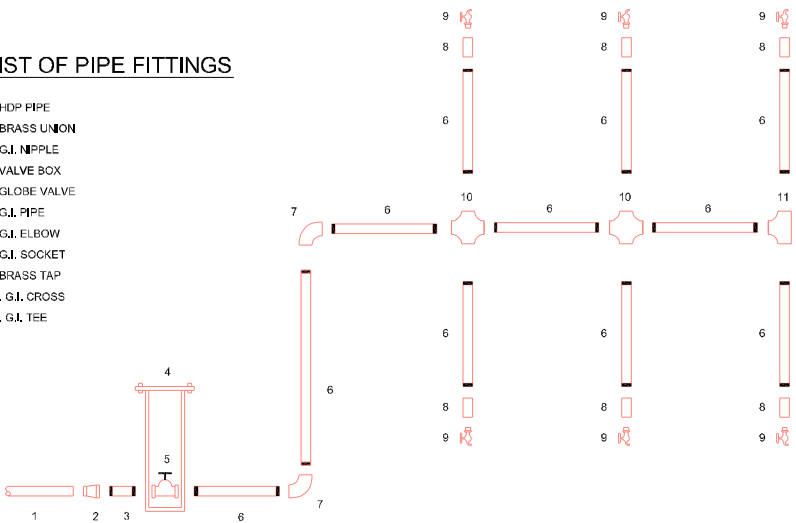

SIDE ELEVATION
(SCALE 1:25)

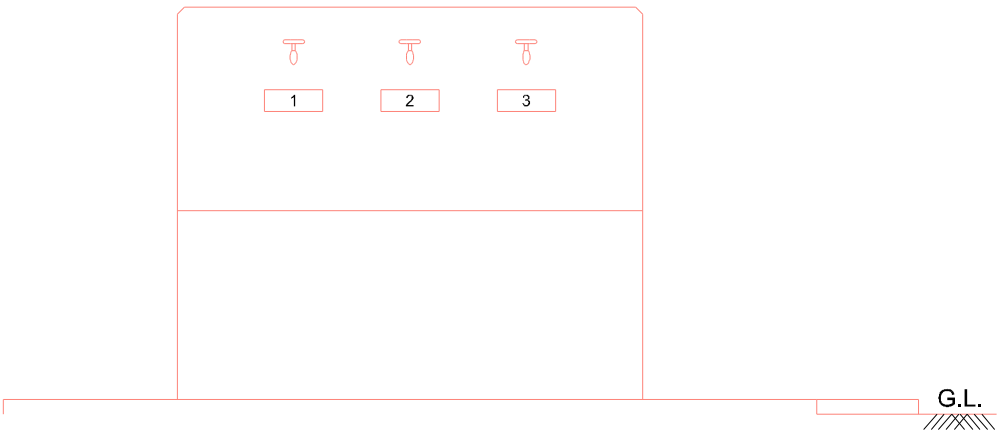

FRONT ELEVATION
(SCALE 1:25)

ALIGHT

DRAWING TITLE:
DESIGNED BY:
DRAWN BY:
CHECKED BY:
APPROVED BY:

WATER KIOSK

H.M.D