



Project Name:
GPE



Drawing By:

GPE Construction Engineer

Checked By:

Kaise Abdi
Title: Construction TA.

Drawing Name:


EXTENTION OF
CLASSROOMS
IN TARGET SCHOOL.

Date : 22/Aug/2024

Scale : 1:100

Note:

All dimesnions
are in meter.

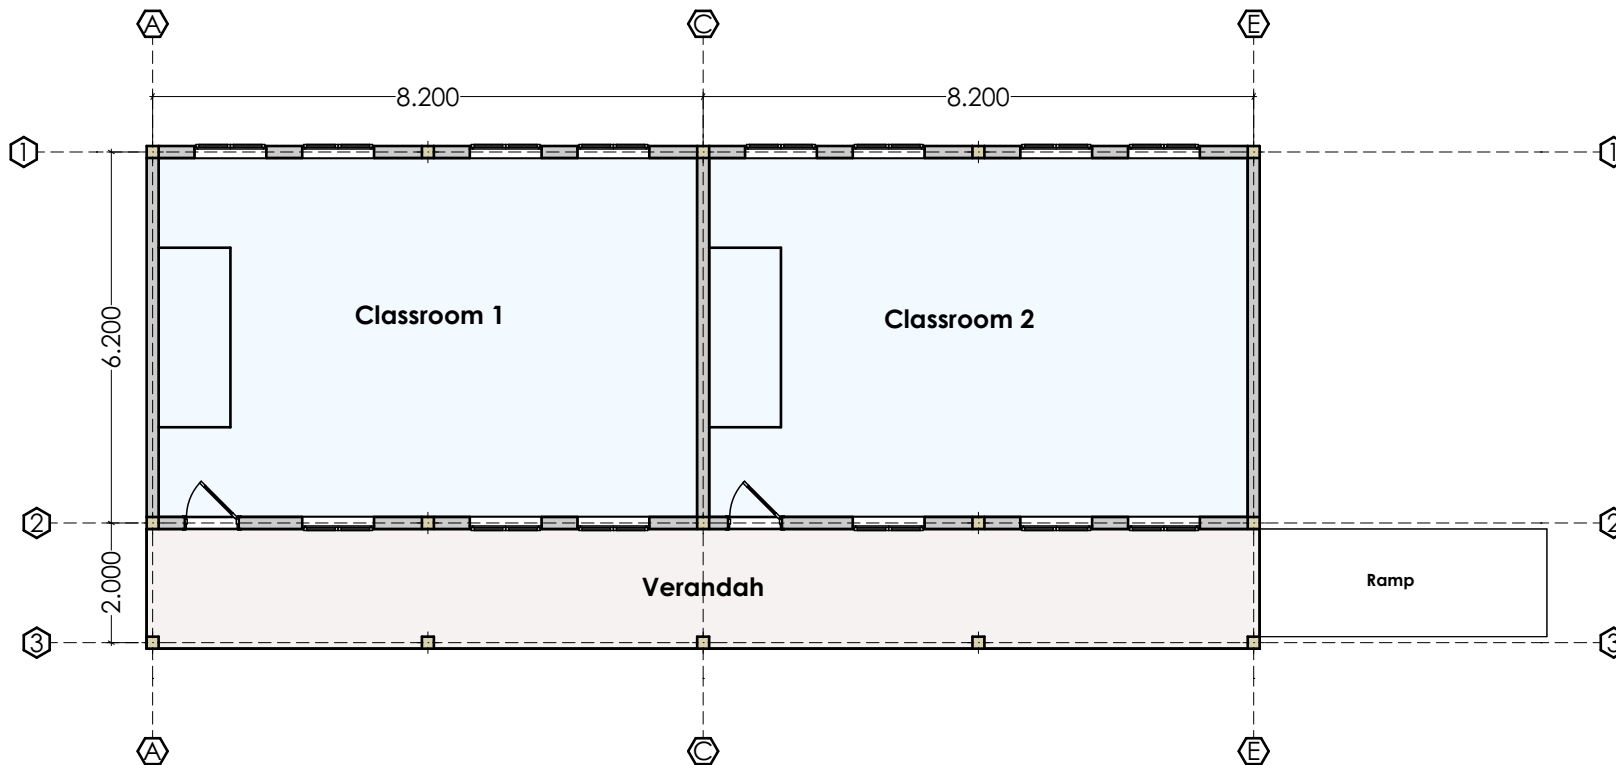

Wall plan



Project Name:
GPE



Drawing By:

GPE Construction Engineer

Checked By:

Kaise Abdi

Title: Construction TA.

Drawing Name:


EXTENTION OF
CLASSROOMS
IN TARGET SCHOOL.

Date : 22/Aug/2024

Scale : 1:100

Note:

All dimesnions
are in meter.

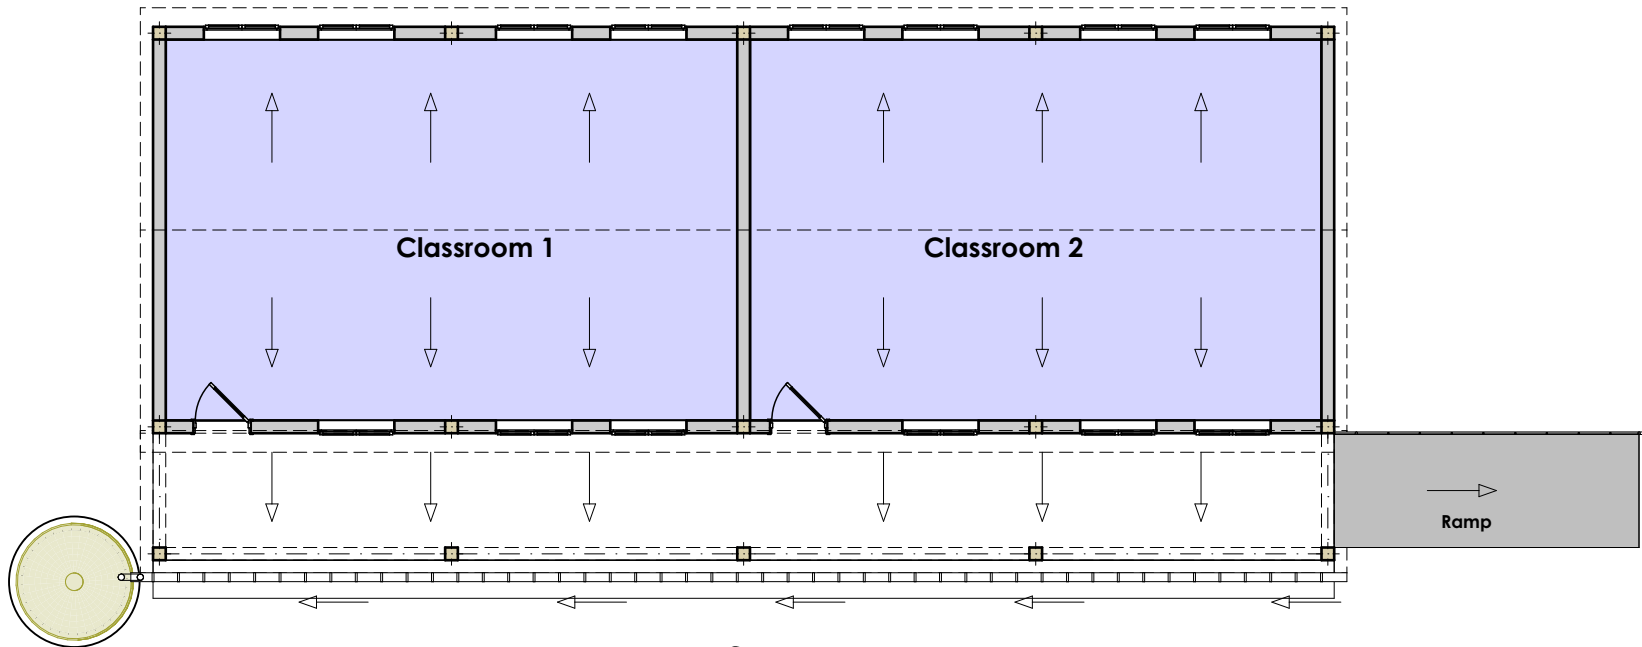

Roof Plan



Project Name:

GPE



Drawing By:

GPE Construction Engineer

Checked By:

Kaise Abdi

Title: Construction TA.

Drawing Name:


EXTENTION OF
CLASSROOMS
IN TARGET SCHOOL.

Date : 22/Aug/2024

Scale : 1:100

Note:

All dimesnions
are in meter.

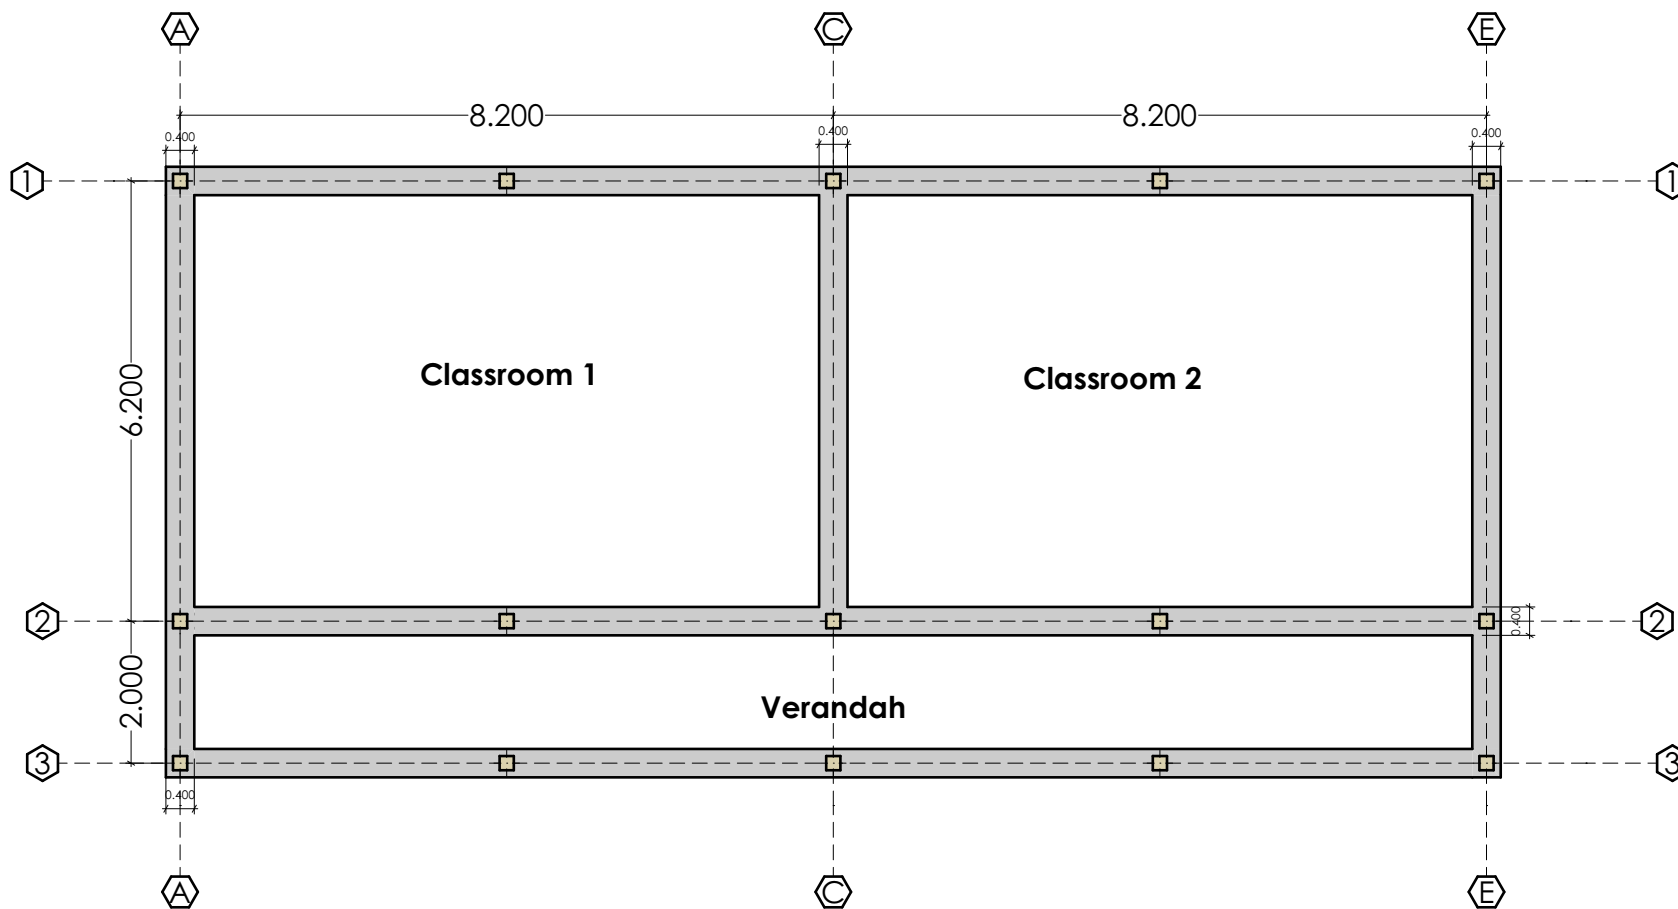

Foundation plan



Project Name:
GPE



Drawing By:

GPE Construction Engineer

Checked By:

Kaise Abdi
Title: Construction TA.

Drawing Name:


EXTENTION OF
CLASSROOMS
IN TARGET SCHOOL.

Date : 22/Aug/2024

Scale : 1:100

Note:

All dimesnions
are in meter.

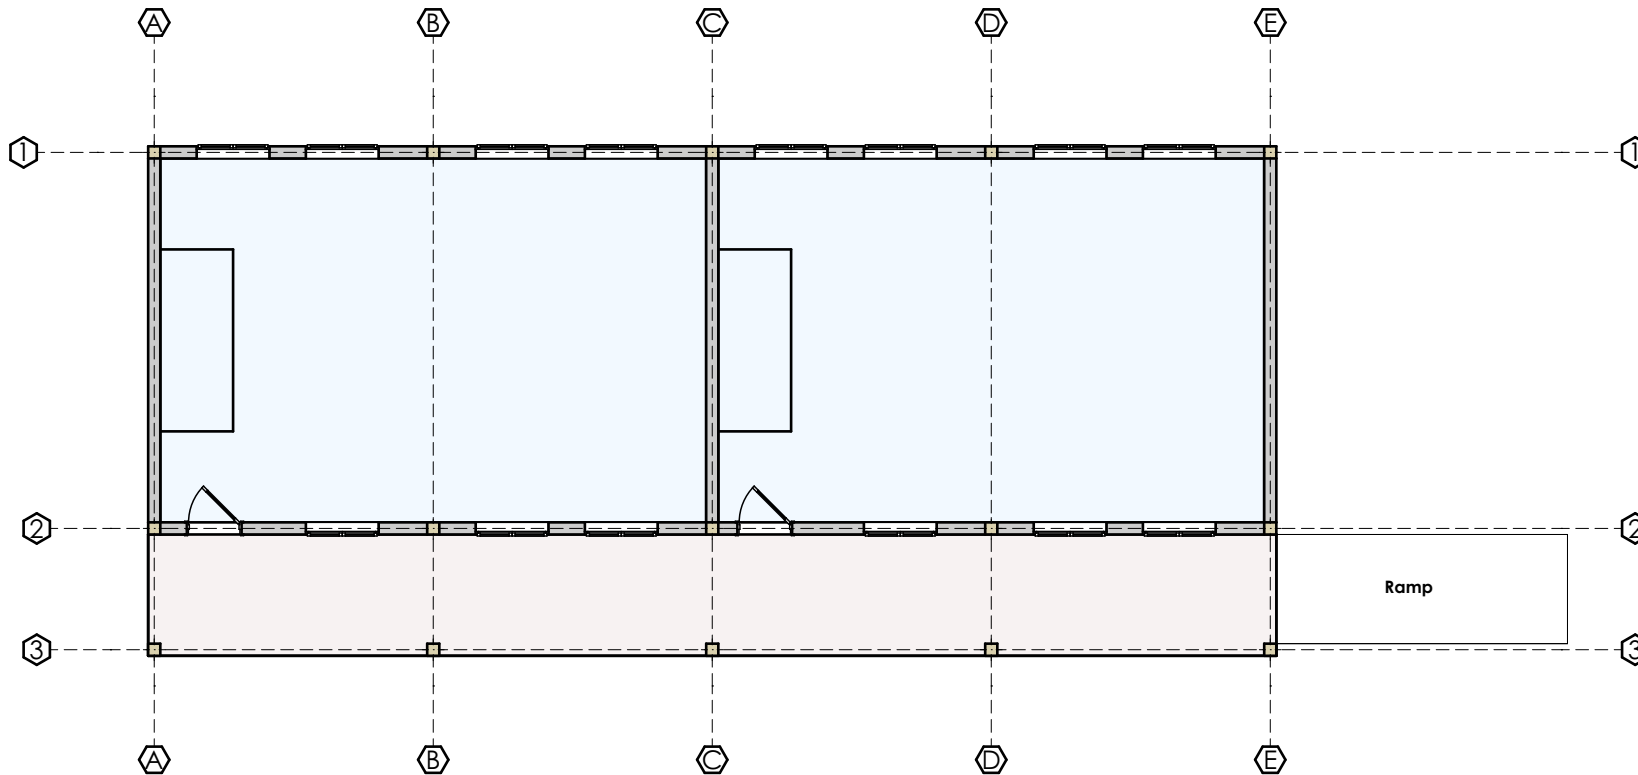

Footing Plan



Project Name:
GPE



Drawing By:

GPE Construction Engineer

Checked By:

Kaise Abdi

Title: Construction TA.

Drawing Name:


EXTENTION OF
CLASSROOMS
IN TARGET SCHOOL.

Date : 22/Aug/2024

Scale : 1:100

Note:

All dimesnions
are in meter.

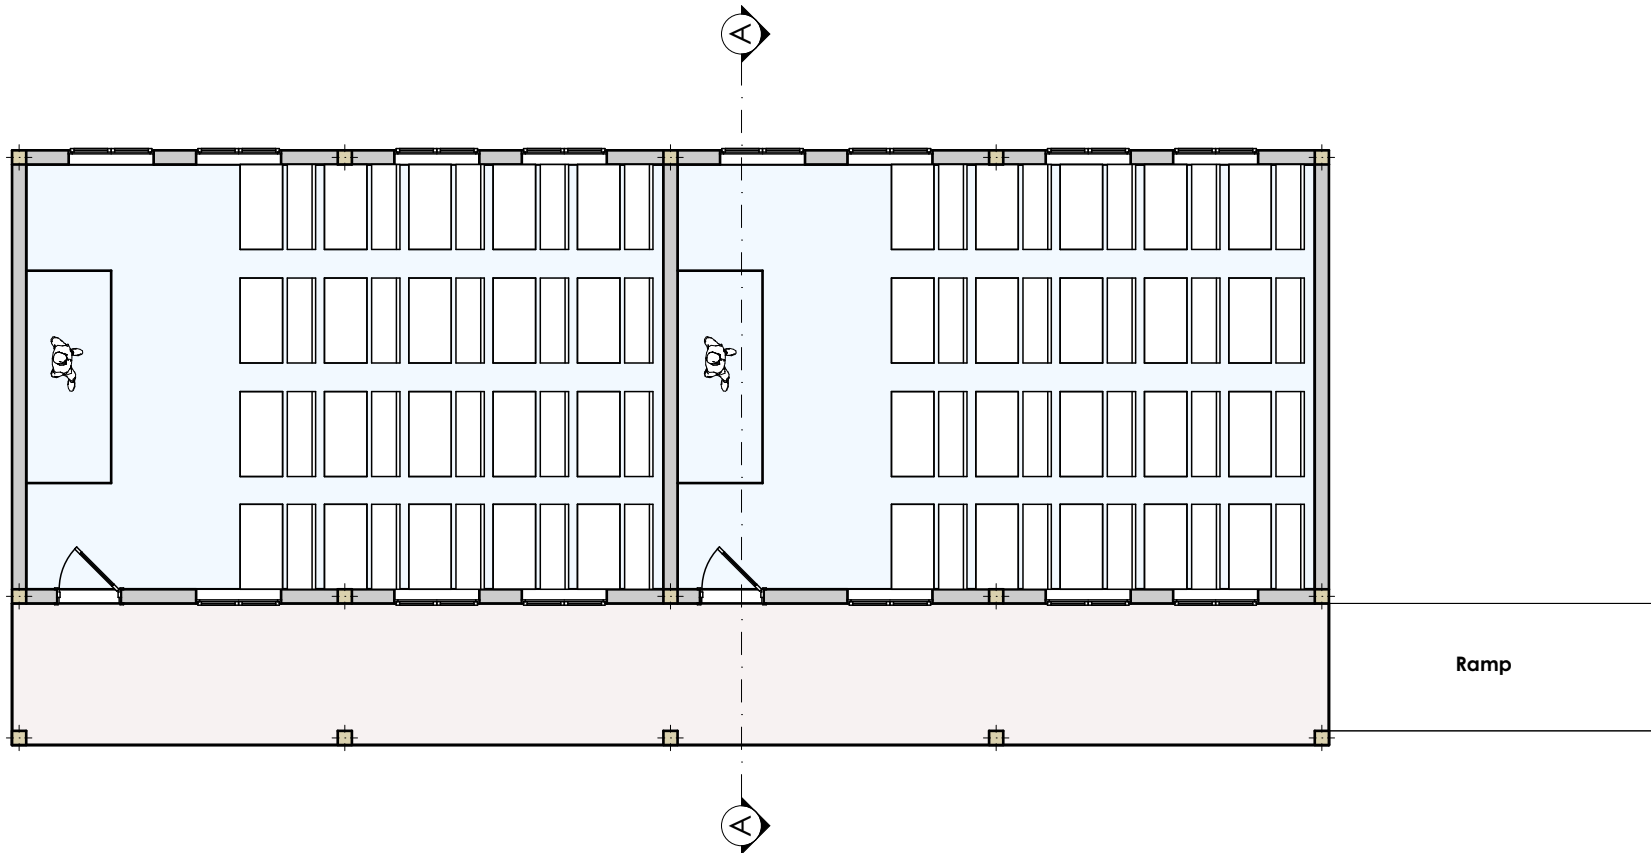

Furniture Plan



Project Name:
GPE



Drawing By:

GPE Construction Engineer

Checked By:

Kaise Abdi

Title: Construction TA.

Drawing Name:


EXTENTION OF
CLASSROOMS
IN TARGET SCHOOL.

Date : 22/Aug/2024

Scale : 1:100

Note:

All dimesnions
are in meter.

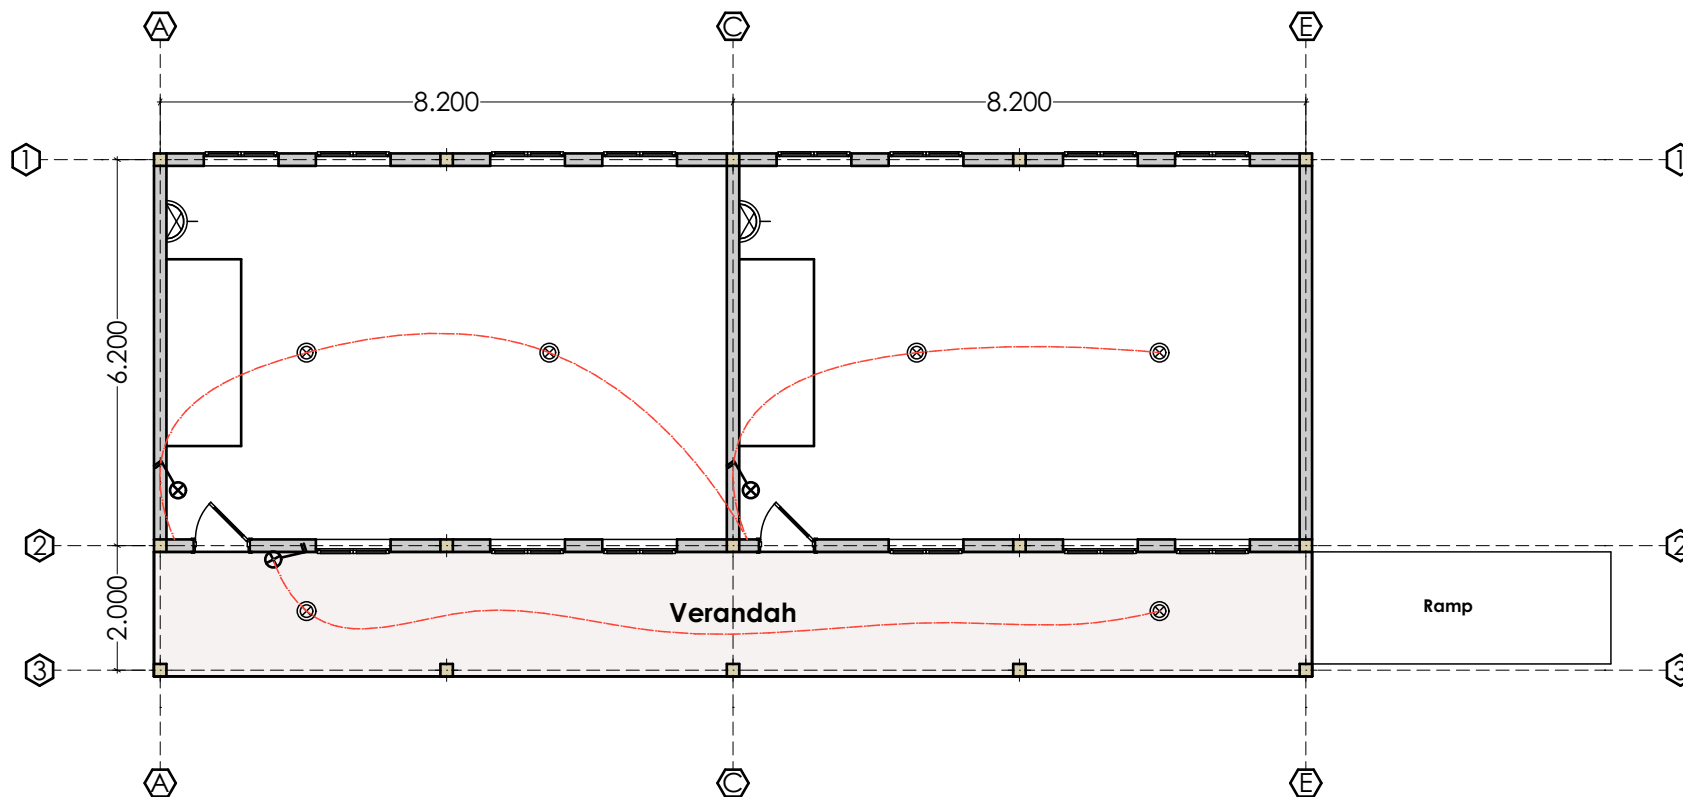

electrical Plan

Project Name:

GPE

GPE Transforming Education

Drawing By:

GPE Construction Engineer

Checked By:

Kaise Abdi

Title: Construction TA.

Drawing Name:


EXTENSION OF
CLASSROOMS
IN TARGET SCHOOL.

Date : 22/Aug/2024




Scale : 1:100

Note:

All dimesnions
are in meter.

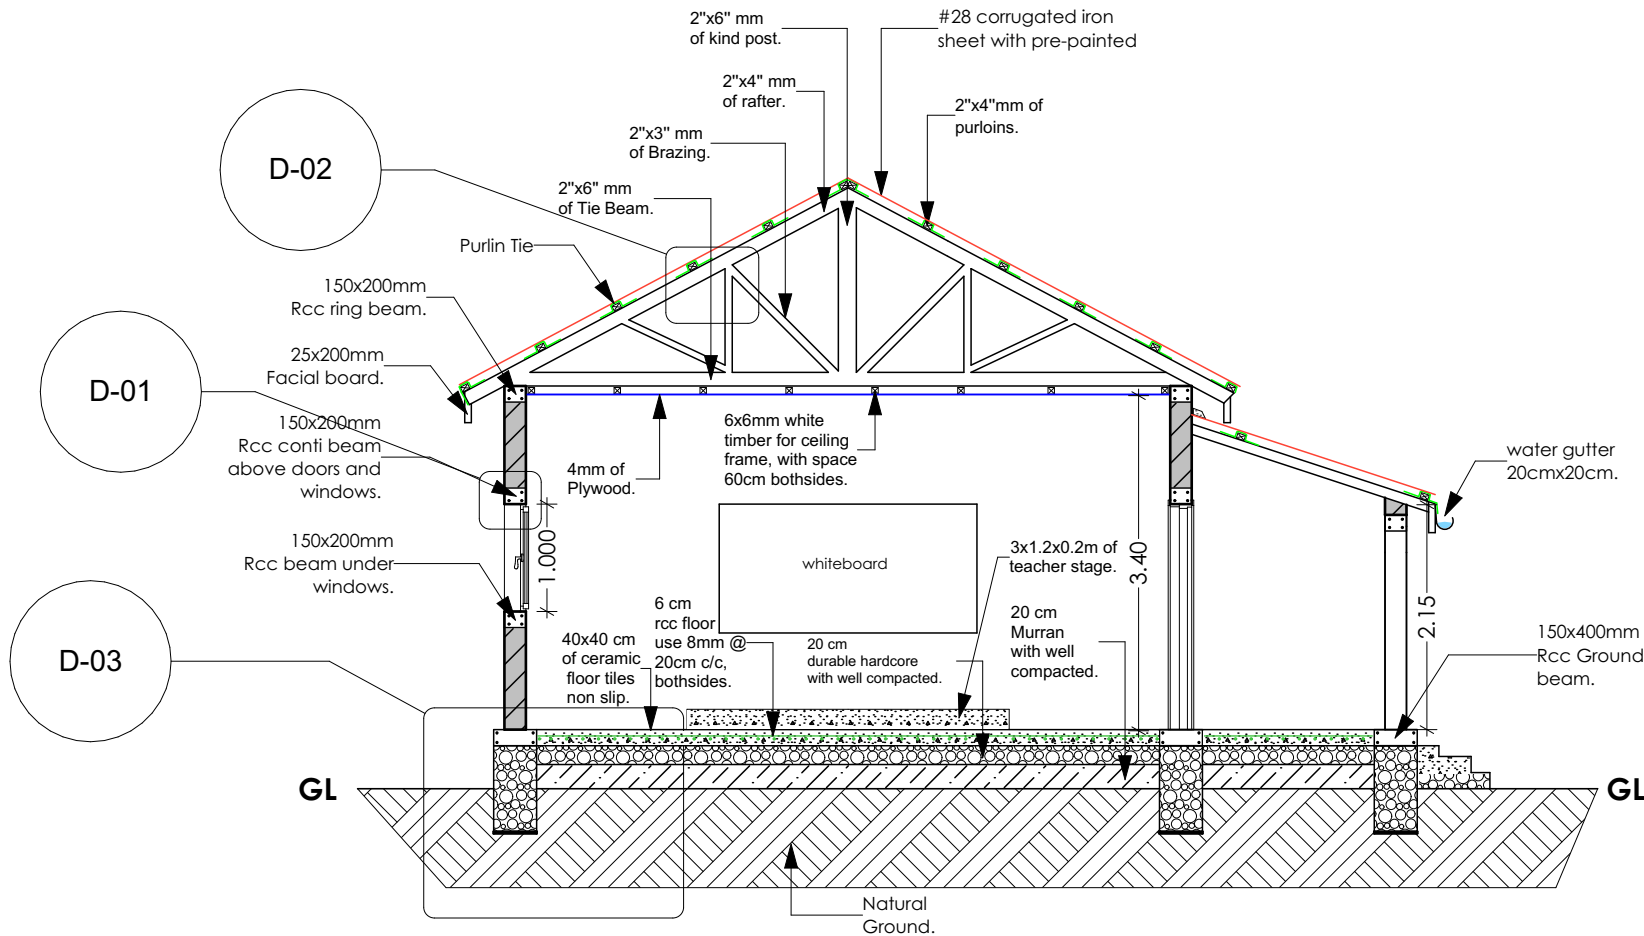

Section AA

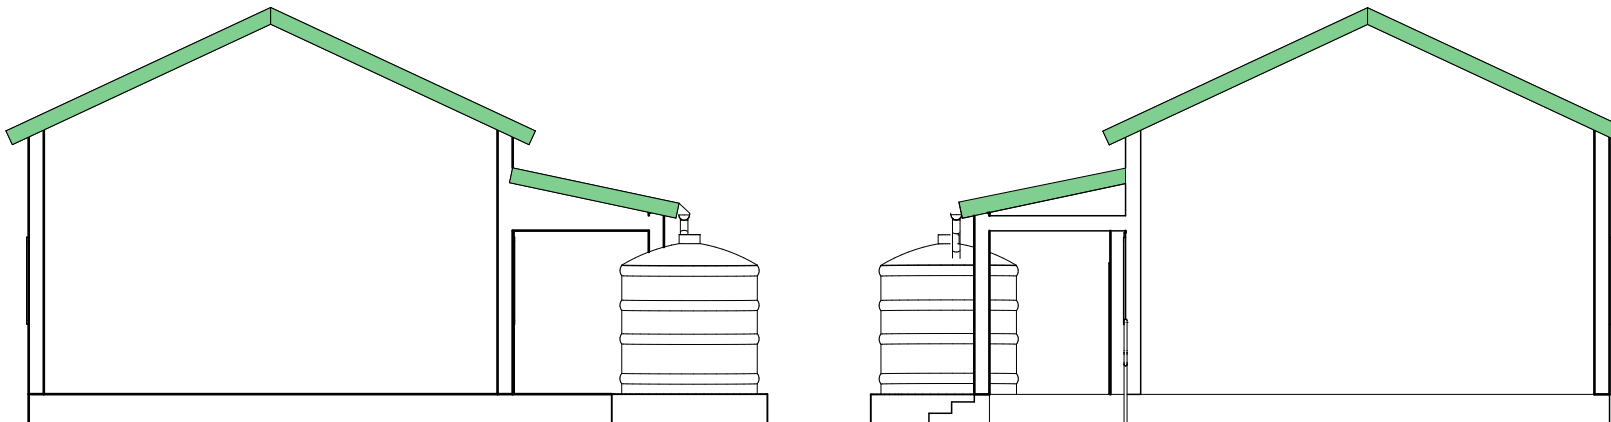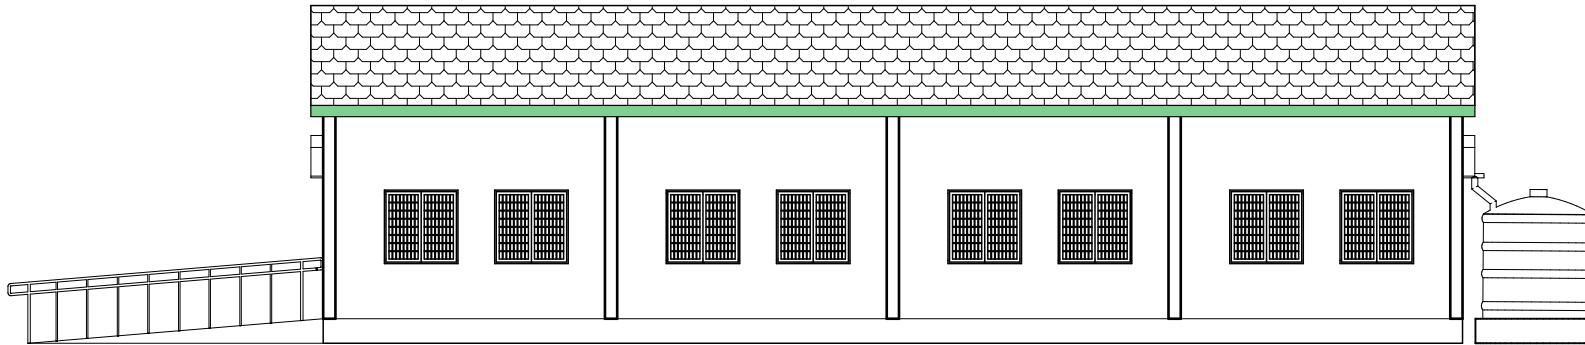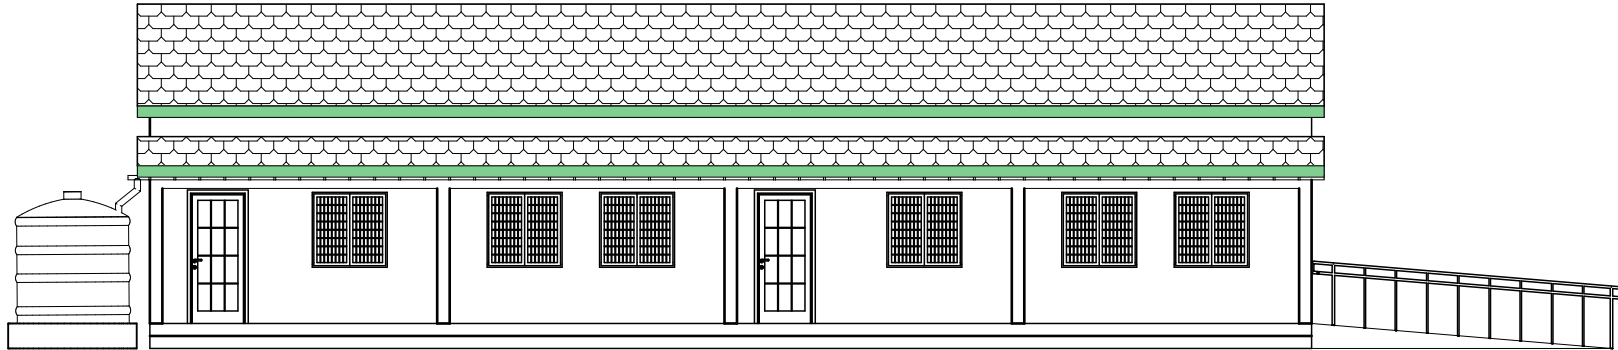

Project Name:
GPE



Drawing By:

GPE Construction Engineer

Checked By:

Kaise Abdi

Title: Construction TA.

Drawing Name:

EXTENTION OF
CLASSROOMS
IN TARGET SCHOOL.

Date : 22/Aug/2024

Scale : 1:100

Note:

All dimesnions
are in meter.



GPE



Drawing By:

GPE Construction Engineer

Checked By:

Kaise Abdi

Title: Construction TA.

Drawing Name:

EXTENSION OF
CLASSROOMS
IN TARGET SCHOOL.



Date : 22/Aug/2024

Scale : 1:100





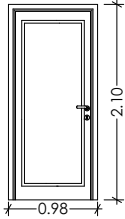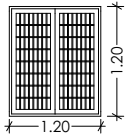


Note:

All dimesnions
are in meter.

Key Legend Doors & Windows.

Symbol of item	Description of item	Quantity
	Regular metallic/steel doors with dimension 1m wide & 2.1m height. see BOQ & Sample in Office SCI.	2 pcs
	2-leaf metallic/steel windows dimensions 1.2m x 1.2m at the back and front sides. see in BOQ and sample in SCI office.	14 Pcs

Key Legend electrical system

Symbol of item	Description of item	Quantity
	Lamp 40w bulb, with holder.	6 pcs
	2-gang 2-way switch screwfix	4 pcs
	2-gang socket screwfix Socket White.	2 pcs
	Circuit Breaker Panel Garage-4 way-63A.	1 pcs
	2.5mm thicknes of electrical wiring.	3.0 Rolls
	electrical junction box screwfix.	6 Pcs
	Heavy Duty Round PVC Conduit 2m Black pipe under walls.	10 Pcs



Project Name:
GPE



Drawing By:

GPE Construction Engineer



Checked By:
Kaise Abdi
Title: Construction TA.

Drawing Name:
EXTENTION OF
CLASSROOMS
IN TARGET SCHOOL.

Date : 22/Aug/2024

Scale : 1:100

Note:
All dimesnions
are in meter.

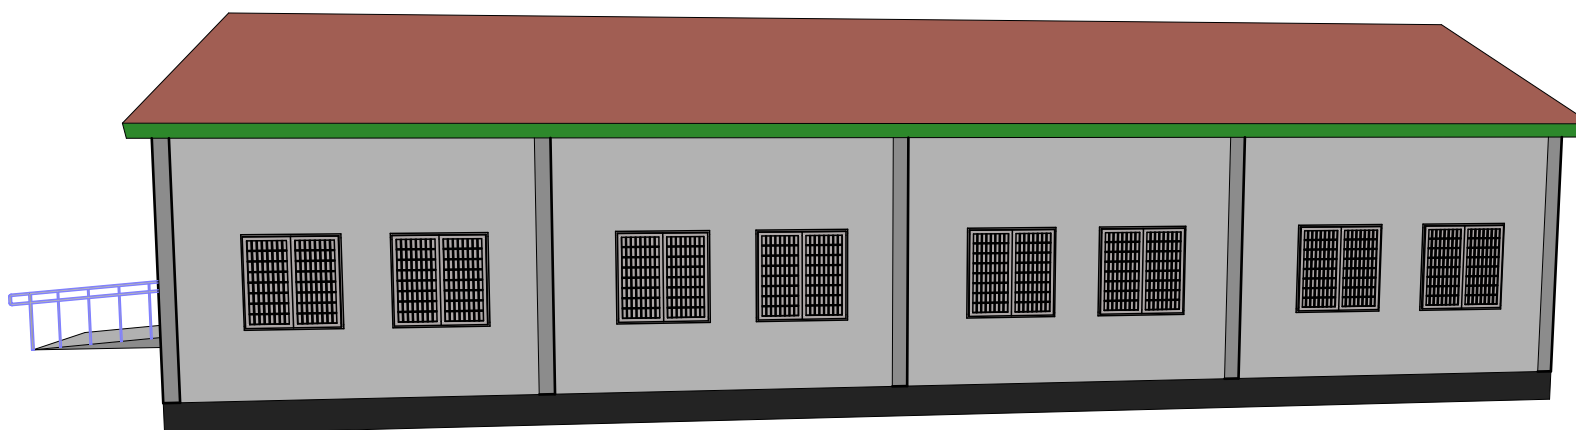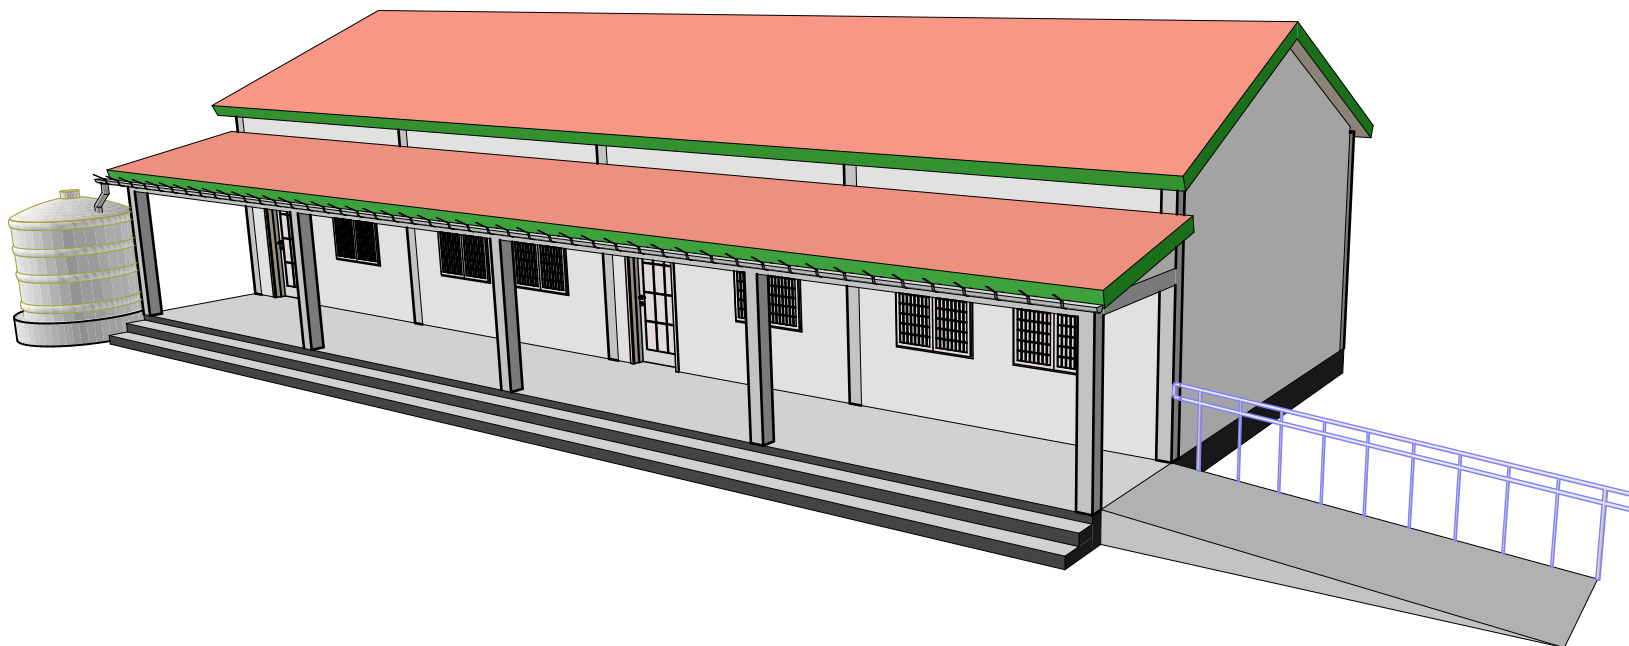

Project Name:
GPE



Drawing By:

GPE Construction Engineer

Checked By:

Kaise Abdi

Title: Construction TA.

Drawing Name:

EXTENTION OF
CLASSROOMS
IN TARGET SCHOOL.

Date : 22/Aug/2024

Scale : 1:100

Note:

All dimesnions
are in meter.